

Extinguisher

Fire buckets


Hose Reel/Rack

First Aid

Emergency Exit

Standpipe Connection

LEGENDS

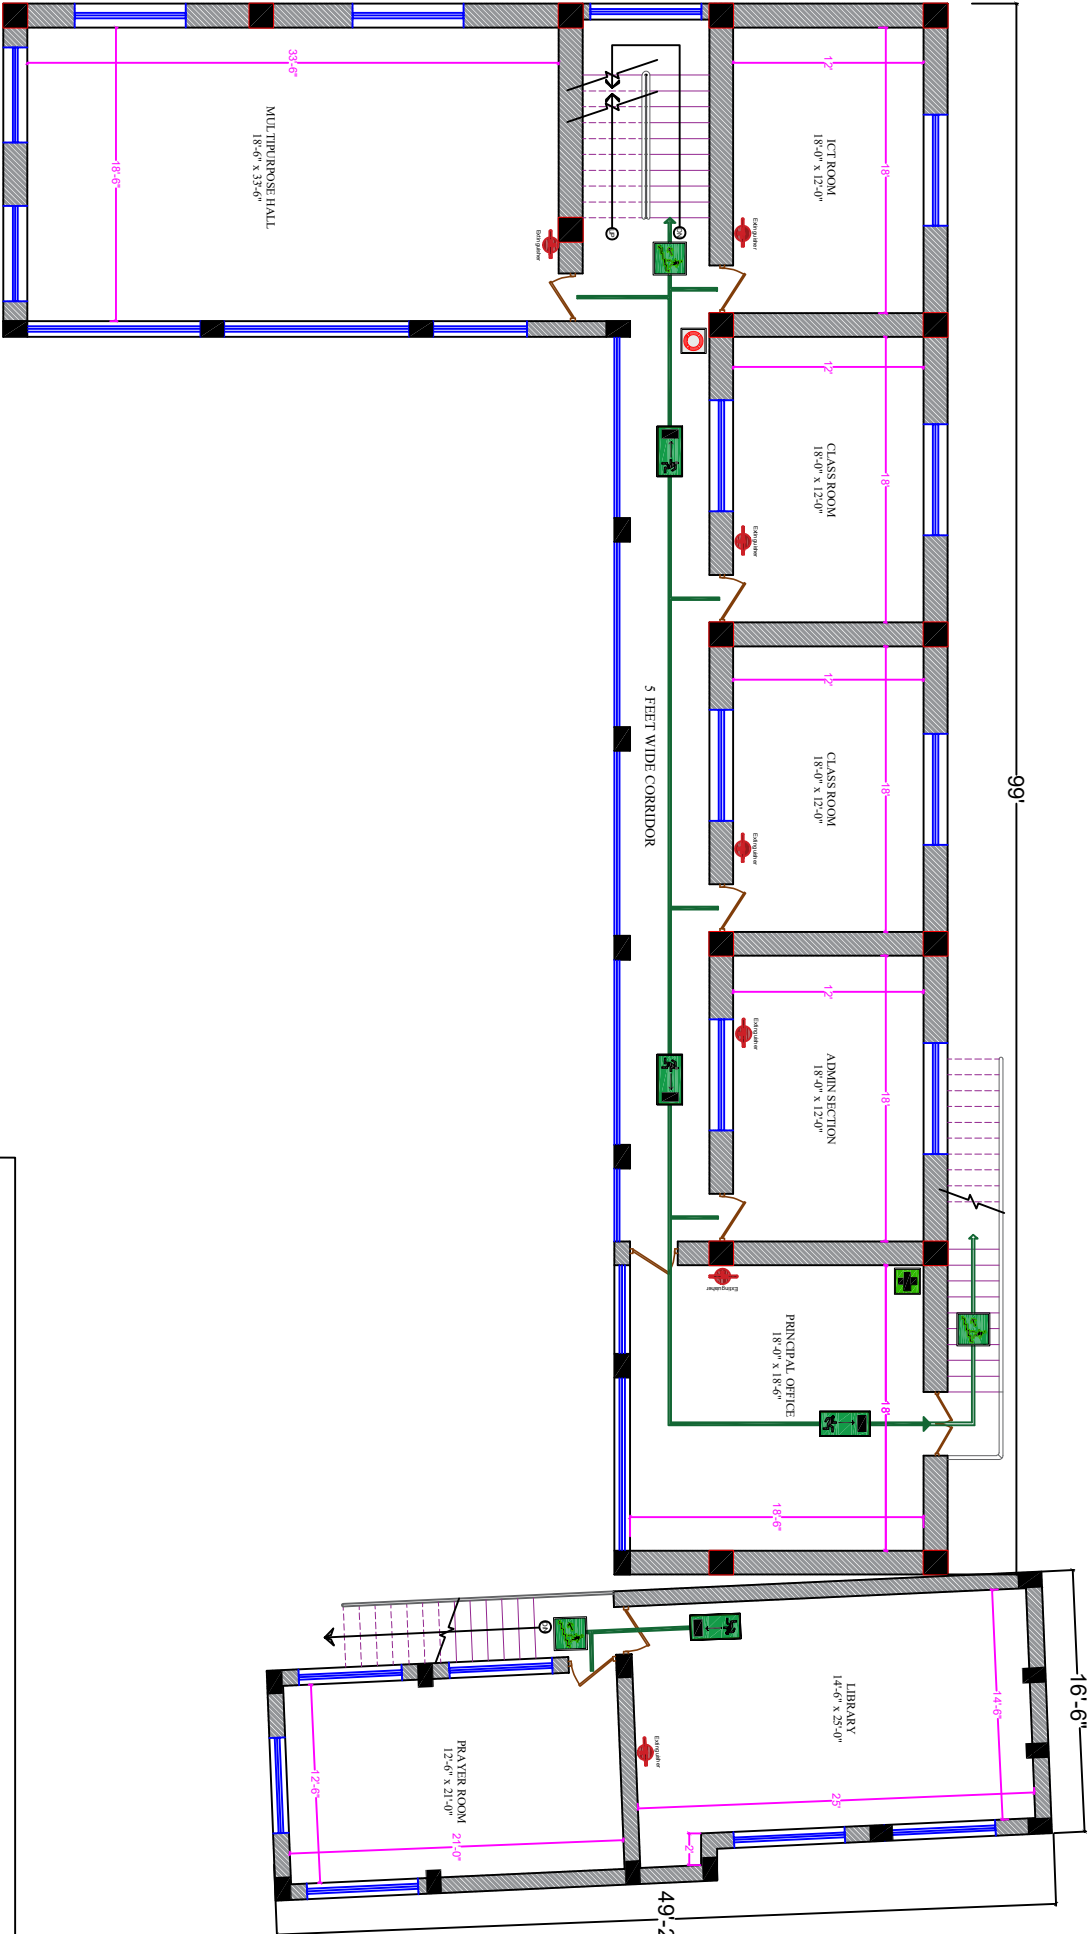

FIRST FLOOR

THIS DRAWING IS THE PROPERTY OF NORTHERN ECO EARTH DESIGN SOLUTION. IT SHALL NOT BE REPRODUCED, COPIED, USED IN ANY MANNER OR HANDED OVER TO ANY OTHER PERSON OR PARTY, WITHOUT THE PRIOR PERMISSION OF THE PRINCIPAL ARCHITECT.

PROJECT TITLE:
FIRE SAFETY PLAN OF GOVT HIGH SCHOOL TAIKAT, BARSOO

CLIENT

SHEET TITLE:
FLOOR PLAN

DRAWN BY : Ar. Sharafat Mehdi

CHECKED BY : Ar. Sheeba

PROJECT NO.
LA-26-24

GOVT HIGH SCHOOL, TAIKAT

DRAWING TITLE :
FIRST FLOOR PLAN

DATE :

SCALE : N.T.S.

DRAWING NO.
AD/03

ARCHITECTURAL CONSULTANTS :
NORTHERN ECO EARTH DESIGN SOLUTION
ARCHITECTS, PLANNERS, INTERIORS, LANDSCAPE, ENGINEERS
Head Office at Baroo Kangri, Ladakh Email: needsolutions360@gmail.com

SOUTH

